



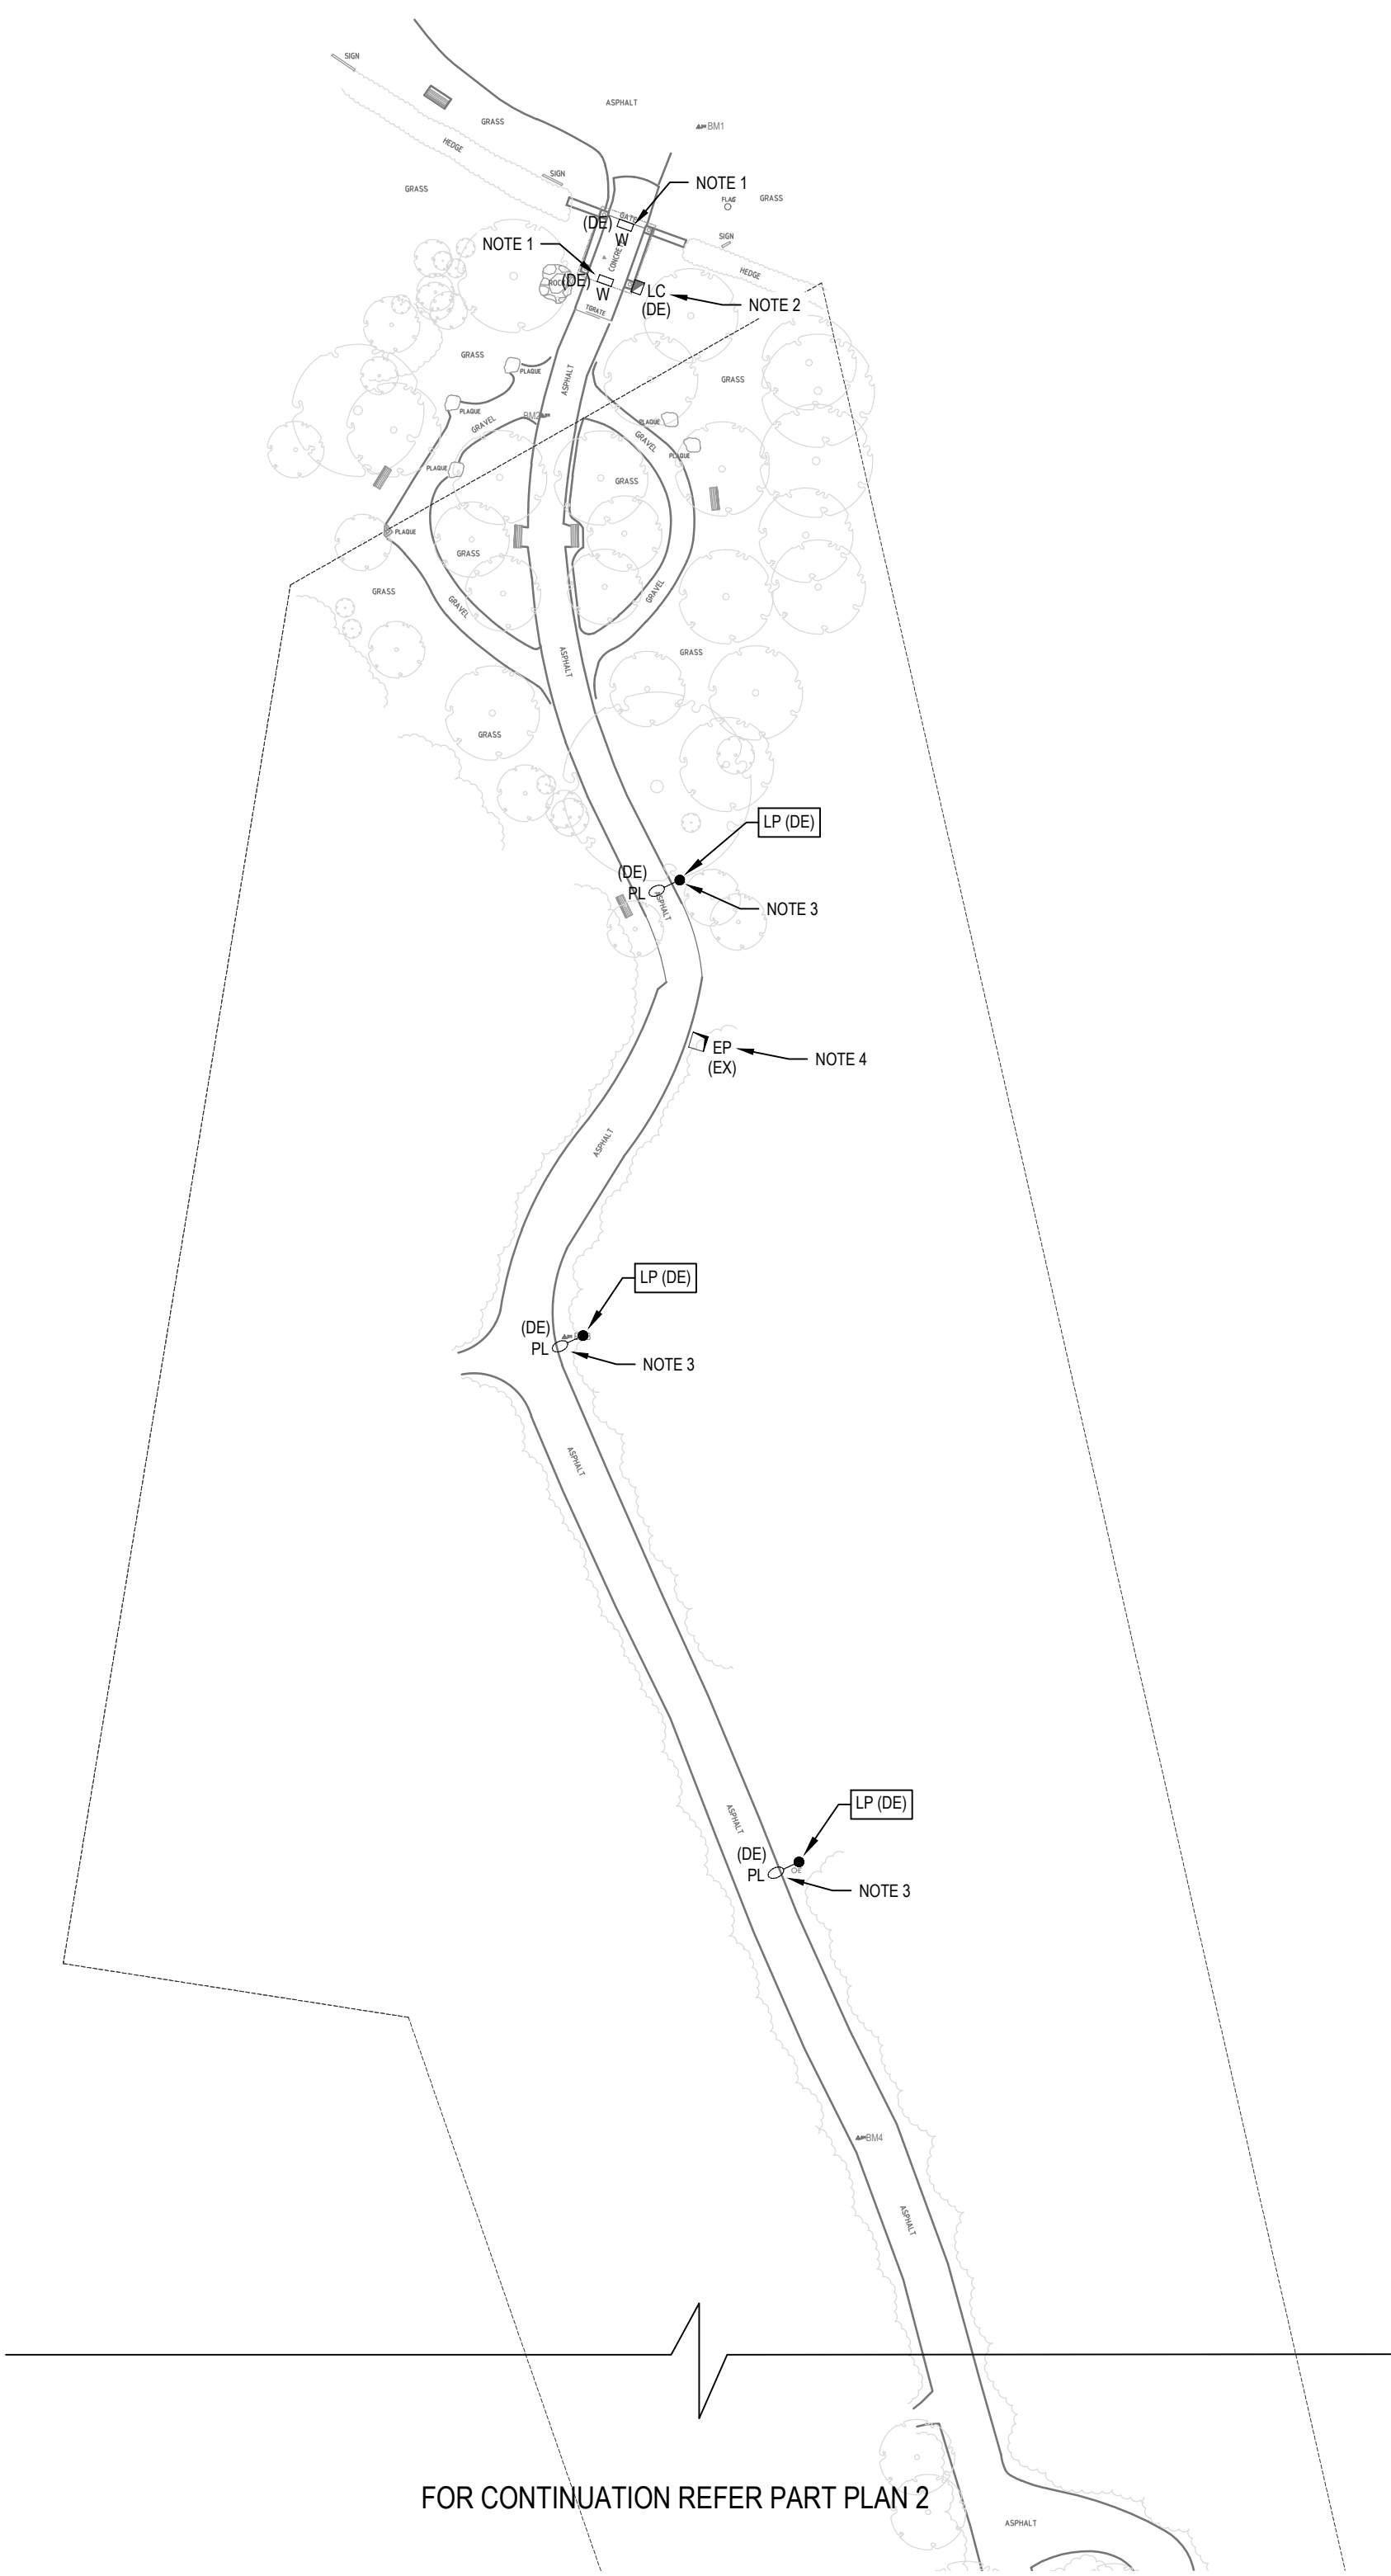

PART PLAN 1

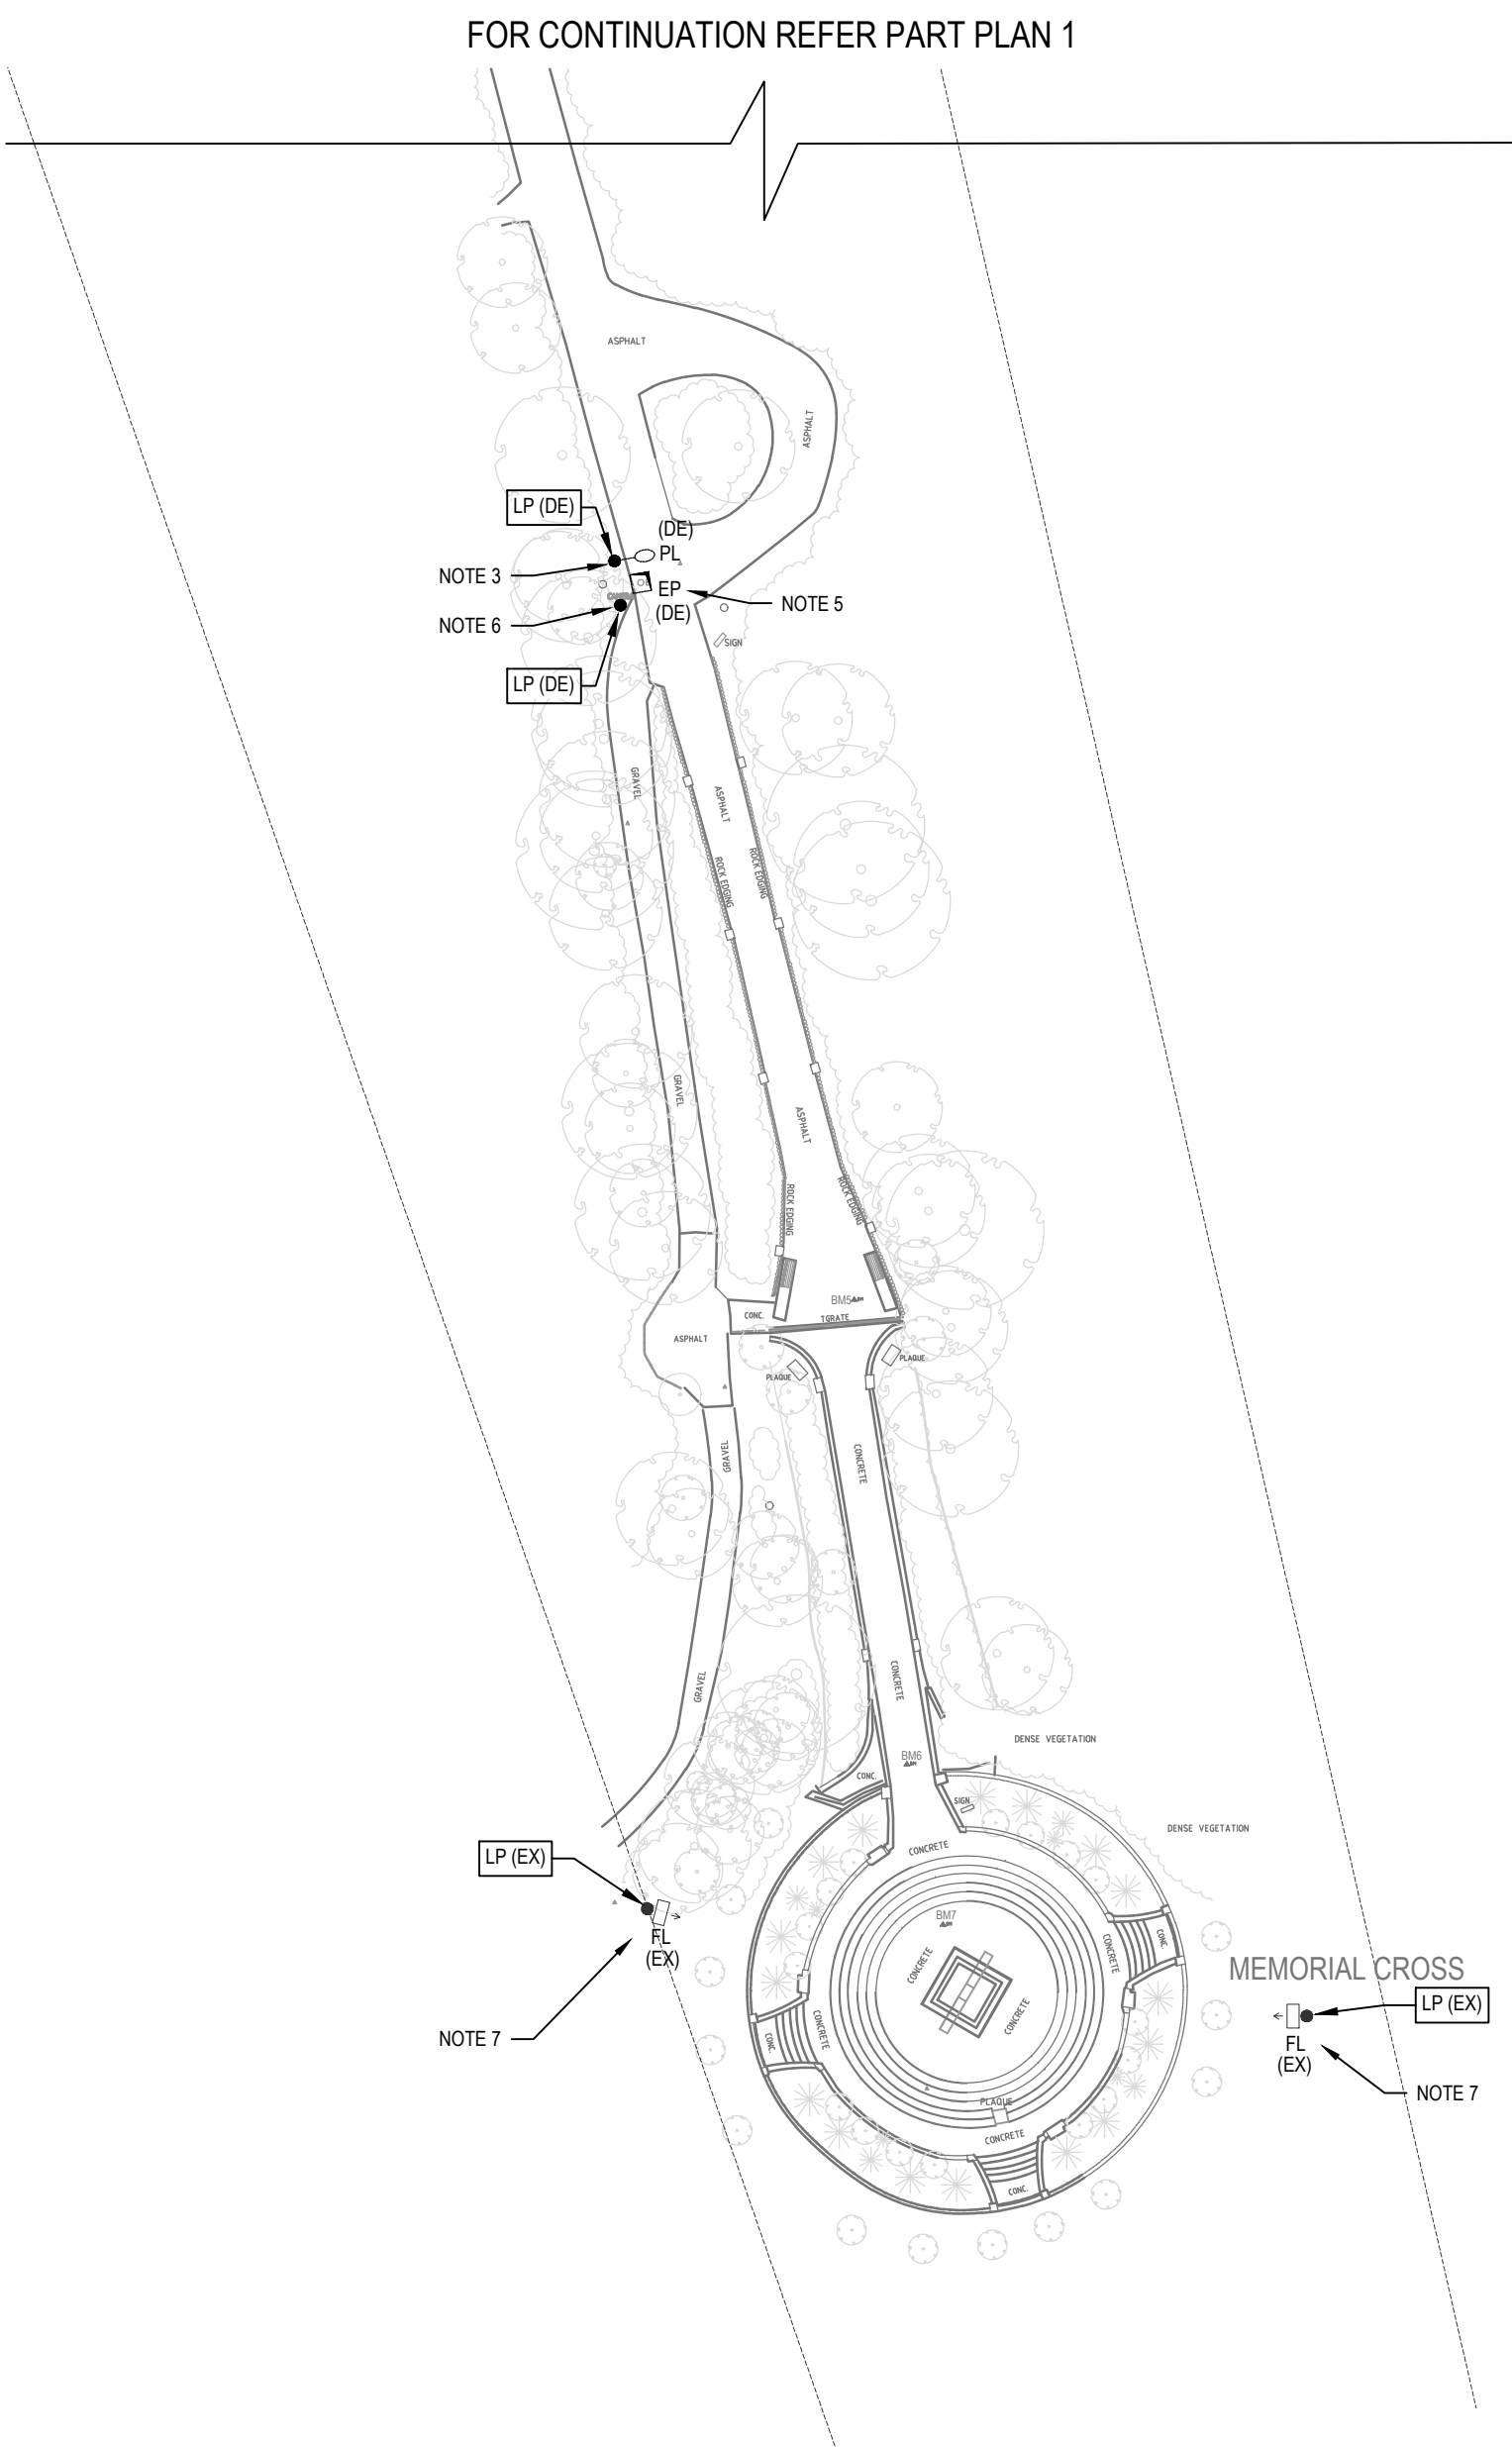

PART PLAN 2

- NOTES:**
1. EXISTING SURFACE MOUNTED LUMINAIRE COMPLETE WITH SURFACE MOUNTED SUB-CIRCUIT WIRING & CONDUIT TO BE DISCONNECTED & REMOVED.
 2. EXISTING LOAD CENTRE SWITCHBOARD COMPRISING CIRCUIT BREAKER, TIME CLOCK & AUTO/OFF/MANUAL SELECTOR SWITCH TO BE DISCONNECTED & REMOVED TOGETHER WITH ASSOCIATED SUB-CIRCUIT WIRING & WIRING ENCLOSURES.
 3. EXISTING LED LUMINAIRE POLE MOUNTED TO BE DISCONNECTED IN ENTIRETY INCLUSIVE OF POLE, CONCRETE FOOTING, UNDERGROUND CONDUITS AND POLE MOUNTED LOAD CENTRE SWITCHBOARD COMPRISING CIRCUIT BREAKER, TIME CLOCK & AUTO/OFF/MANUAL SELECTOR SWITCH.
 4. EXISTING IN-GROUND CABLE PIT AND INCOMING SUB-MAIN CABLING FROM EXISTING AMENITIES DISTRIBUTION SWITCHBOARD TO REMAIN FOR REUSE ASSOCIATED WITH PROPOSED PATHWAY LIGHTING INSTALLATION.
 5. EXISTING IN-GROUND CABLE PIT AND UNDERGROUND CONDUITS AND SUB-MAIN CABLING TO BE DISCONNECTED AND REMOVED.
 6. EXISTING CCTV CAMERA POLE TO BE DISCONNECTED AND REMOVED INCLUSIVE OF FOUNDATIONS, IN-GROUND CABLING AND ASSOCIATED CONDUITS.
 7. EXISTING POLE MOUNTED LED FLOOD LIGHTING AND WEATHERPROOF POWER OUTLETS TO REMAIN UNALTERED & FULLY OPERATIONAL. RECONNECT EXISTING FLOOD LIGHTS AS NOTED ON THE PROPOSED ELECTRICAL RETICULATION SCHEMATICS DRAWING E04.

TD-B	24.10.2024	REVISED TENDER DOCUMENTATION ISSUE	SW
TD-A	19.09.2024	TENDER DOCUMENTATION ISSUE	S.R.
TR-B	05.08.2024	REVISED TENDER REVIEW ISSUE	S.R.
TR-A	21.06.2024	TENDER REVIEW ISSUE	S.R.
REV	DATE	DESCRIPTION	INITIAL

© JBA Consulting Engineers Pty Ltd.
All Rights Reserved.

This document is copyright and is not to be reproduced or copied in whole or in part without prior written approval from JBA. It is uncontrolled, not subject to update, shows design intent only and is subject to the work product terms and conditions found at <http://www.jba.com.au/legal/doctype/> which must be read in as forming part of this disclaimer.



smarter
engineering

phone (03) 9646 9144 web www.jba.com.au

CLIENT

MOUNT MACEDON MEMORIAL CROSS RESERVE COMMITTEE OF MANAGEMENT

ARCHITECT



PROJECT

MOUNT MACEDON MEMORIAL CROSS PATHWAY LIGHTING UPGRADE


SERVICE

ELECTRICAL SERVICES

TITLE

EXISTING SITE PLAN

DESIGNED T.BUSH	DRAWN S.RATNAYAKE	PROJECT LEADER T.BUSH
SCALE @ A1 1:500	COMMENCED DATE MAY 2024	SHEET NUMBER 2 of 4

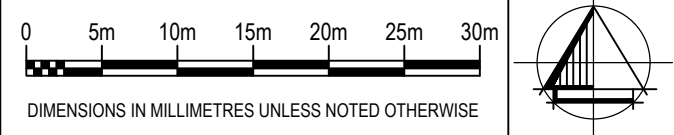

**TENDER
NOT FOR CONSTRUCTION**

PROJECT NUMBER 4880	DRAWING NUMBER E02	REVISION TD-B
-------------------------------	------------------------------	-------------------------

FOR CONTINUATION REFER PART PLAN 2

PART PLAN 1

PART PLAN 2

NOTES:

1. LIGHT FITTING SURFACE MOUNTED TO UNDERSIDE OF ROOF OF EXISTING ENTRANCE STRUCTURE. EXACT LOCATION OF LIGHT FITTING TO BE CONFIRMED ON SITE PRIOR TO INSTALLATION AND WIRING ROUGH-IN.
2. CONDUIT STUBS TO BE INSTALLED OUT OF ELECTRICAL PIT FOR FUTURE CONNECTION.
3. EXISTING CONDUIT & SUB-MAIN CABLEING FROM EXISTING AMENITIES DISTRIBUTION SWITCHBOARD TO REMAIN AND CONNECTED TO NEW LIGHTING DISTRIBUTION SWITCHBOARD DB-L.
4. FOR CONTINUATION OF UNDERGROUND CONDUITS REFER TO PART PLAN THIS SHEET.
5. CONNECT 1 NO. 40mm DIA HD UG PVC CONDUIT ONTO EXISTING UNDERGROUND CONDUIT ASSOCIATED WITH EXISTING CROSS POLE MOUNTED FLOOD LIGHTS.
6. EXISTING POLE MOUNTED LED FLOOD LIGHTING AND WEATHERPROOF POWER OUTLETS TO REMAIN UNALTERED & FULLY OPERATIONAL. RECONNECT EXISTING FLOOD LIGHTS AS NOTED ON THE PROPOSED ELECTRICAL RETICULATION SCHEMATIC DRAWING E04.
7. PROVIDE 2 NO. 40mm DIA HD UG PVC CONDUIT STUBS FROM ELECTRICAL PIT FOR FUTURE CONNECTION.
8. CONDUITS CAPPED OFF FOR FUTURE USE.
9. ALL WIRING ASSOCIATED WITH THE LIGHTING & POWER INSTALLATION TO THE EXISTING ENTRANCE STRUCTURE SHALL BE CONCEALED WITHIN EXPOSED SURFACE MOUNTED GALVANISED STEEL CONDUIT.

TD-B	24.10.2024	REVISED TENDER DOCUMENTATION ISSUE	SW
TD-A	19.09.2024	TENDER DOCUMENTATION ISSUE	S.R.
TR-B	05.08.2024	REVISED TENDER REVIEW ISSUE	S.R.
TR-A	21.06.2024	TENDER REVIEW ISSUE	S.R.
REV.	DATE	DESCRIPTION	INITIAL

© JBA Consulting Engineers Pty Ltd.
All Rights Reserved.

This document is copyright and is not to be reproduced or copied in whole or in part without prior written approval from JBA. It is uncontrolled, not subject to update, shows design intent only and is subject to the work product terms and conditions found at <http://www.jba.com.au/legal/doctermis> which must be read in as forming part of this disclaimer.



phone (03) 9646 9144 web www.jba.com.au

CLIENT

**MOUNT MACEDON MEMORIAL
CROSS RESERVE COMMITTEE
OF MANAGEMENT**

ARCHITECT



PROJECT

MOUNT MACEDON MEMORIAL CROSS PATHWAY LIGHTING UPGRADE


SERVICE

ELECTRICAL SERVICES

TITLE


PROPOSED SITE PLAN

DESIGNED T.BUSH	DRAWN S.RATNAYAKE	PROJECT LEADER T.BUSH
SCALE @ A1 1:500	COMMENCED DATE MAY 2024	SHEET NUMBER 3 of 4

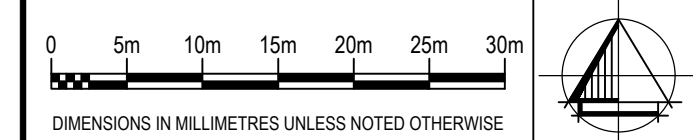[illegible]

TENDER
NOT FOR CONSTRUCTION

PROJECT NUMBER	DRAWING NUMBER	REVISION
4880	E03	TD-B

 

TD-B	24.10.2024	REVISED TENDER DOCUMENTATION ISSUE	SW
TD-A	19.09.2024	TENDER DOCUMENTATION ISSUE	S.R.
TR-B	05.08.2024	REVISED TENDER REVIEW ISSUE	S.R.
TR-A	21.06.2024	TENDER REVIEW ISSUE	S.R.
REV.	DATE	DESCRIPTION	INITIAL

This document is copyright and is not to be reproduced or copied in whole or in part without prior written approval from JBA. It is uncontrolled, not subject to update, shows design intent only and is subject to the work product terms and conditions found at <http://www.jba.com.au/legal/docterms> which must be read in as forming part of this disclaimer.



CLIENT

**MOUNT MACEDON MEMORIAL
CROSS RESERVE COMMITTEE
OF MANAGEMENT**

conservation
studio

PROJECT

**MOUNT MACEDON
MEMORIAL CROSS PATHWAY
LIGHTING UPGRADE**

ELECTRICAL SERVICES

TITLE
**ELECTRICAL RETICULATION
SCHEMATICS & SINGLE LINE DIAGRAMS**

DESIGNED T.BUSH	DRAWN S.RATNAYAKE	PROJECT LEADER T.BUSH
SCALE @ A1 N.T.S.	COMMENCED DATE MAY 2024	SHEET NUMBER 4 of 4

TENDER
NOT FOR CONSTRUCTION

PROJECT NUMBER	DRAWING NUMBER	REVISION
4880	E04	TD-B